


DAVID & KIM

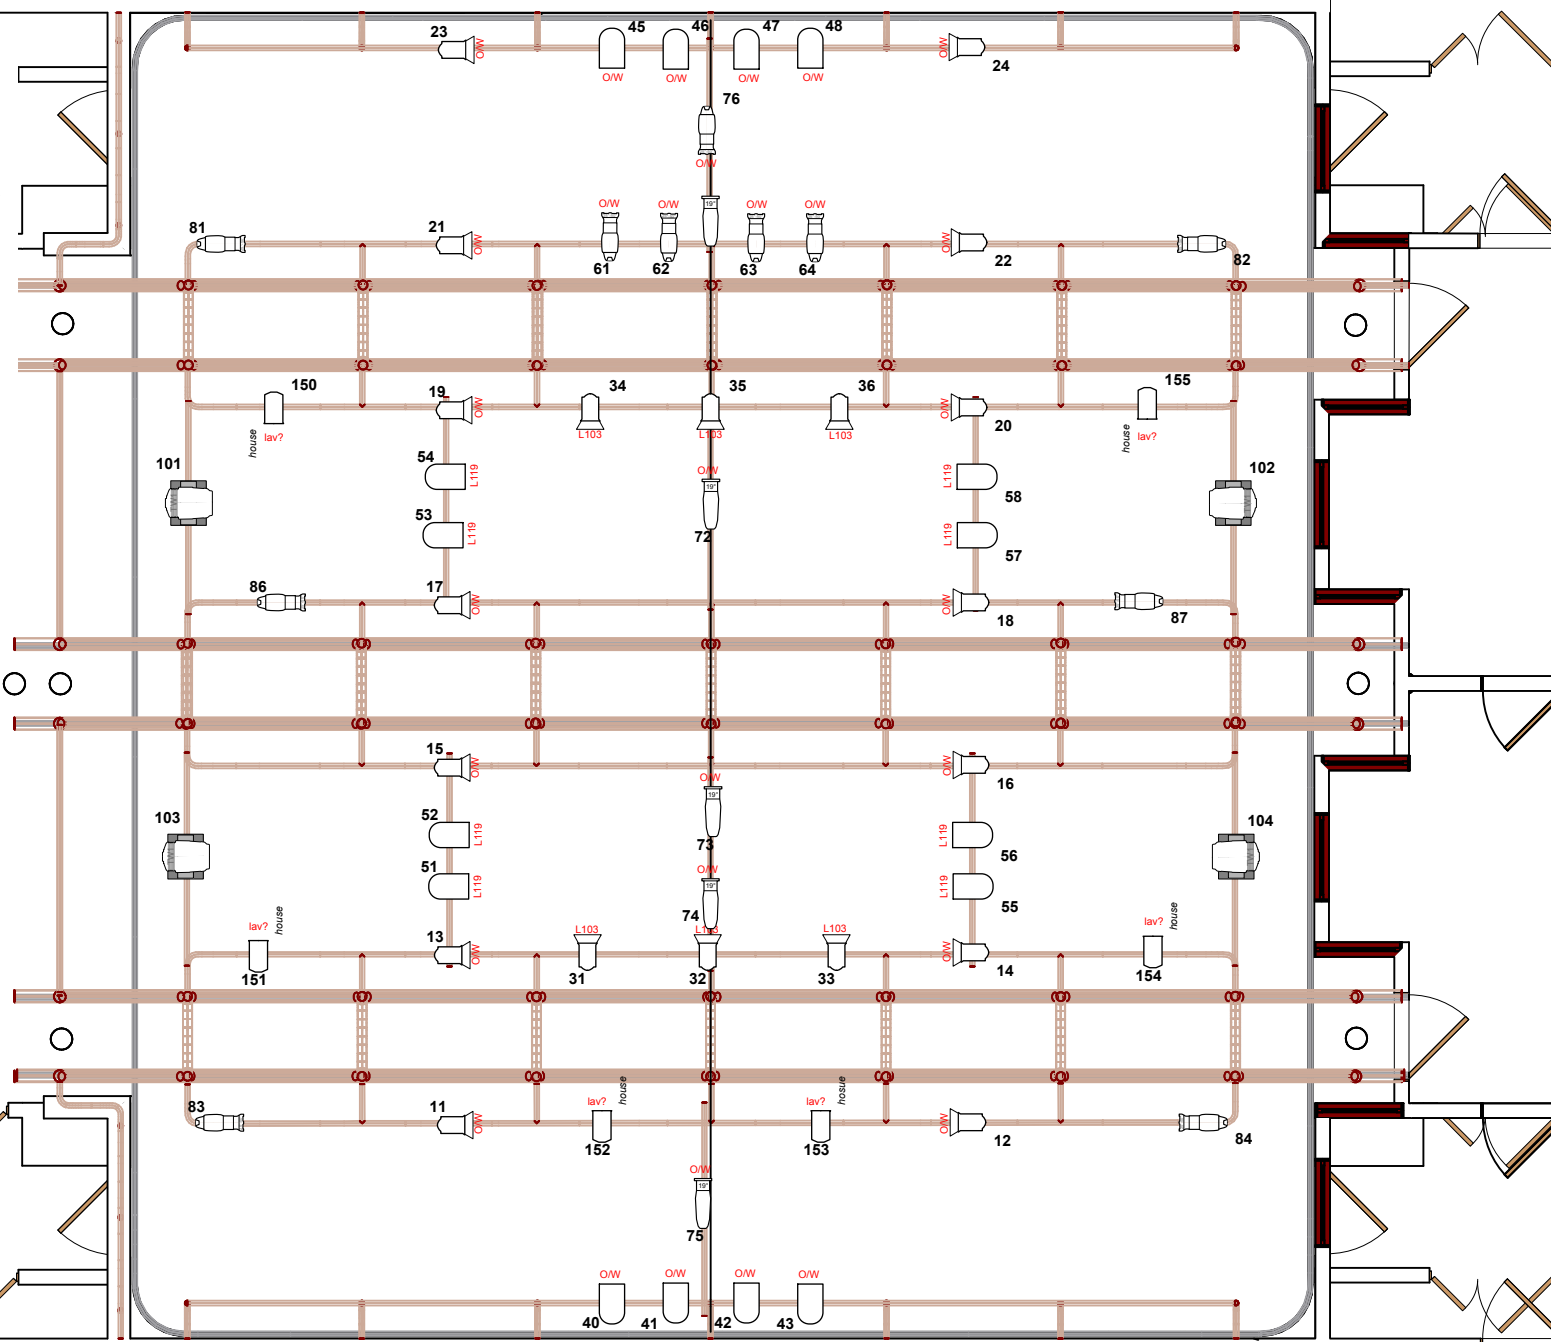

Key to Label Legend

Channel # Unit # Colour Ref. (+F = + Frost)

Xx LXXF
 focus note
 Gobo Reference Colour Reference
 L = Lee Filters
 R = Rosco Filters
 Frost = R119/132

KEY TO INSTRUMENTATION

- Selecon Acclaim Fresnel 650W
- Selecon Acclaim PC 650W
- ETC Source 4 Jnr 25-50 Zoom
- Martin Mac TW1
- PAR 64 - CP62 (WFL)

HAZER : 500

Colour Call

- L201 1/4 CT Blue
- L119 Deep Blue
- L058 Lavender
- L029 Plasa Red
- L103 Straw
- O/W Open White



Royal Conservatoire of Scotland

ALEXANDER RIDGERS
 LIGHTING DESIGN
 07870657721
 A.RIDGERS@HOTMAIL.CO.UK

ALD#

Production Title		Royal Conservatoire of Scotland CPP Year 4 & 1	
Drawing Title		LIGHTING PLAN Version 2 Update 31/05	
Designer	Director		
Drawn By	Scale	--	
Venue	Drawing No.	1	
Date		of	
CAD File Name		1	
RCS_CPP_v.1			