


DRAFT

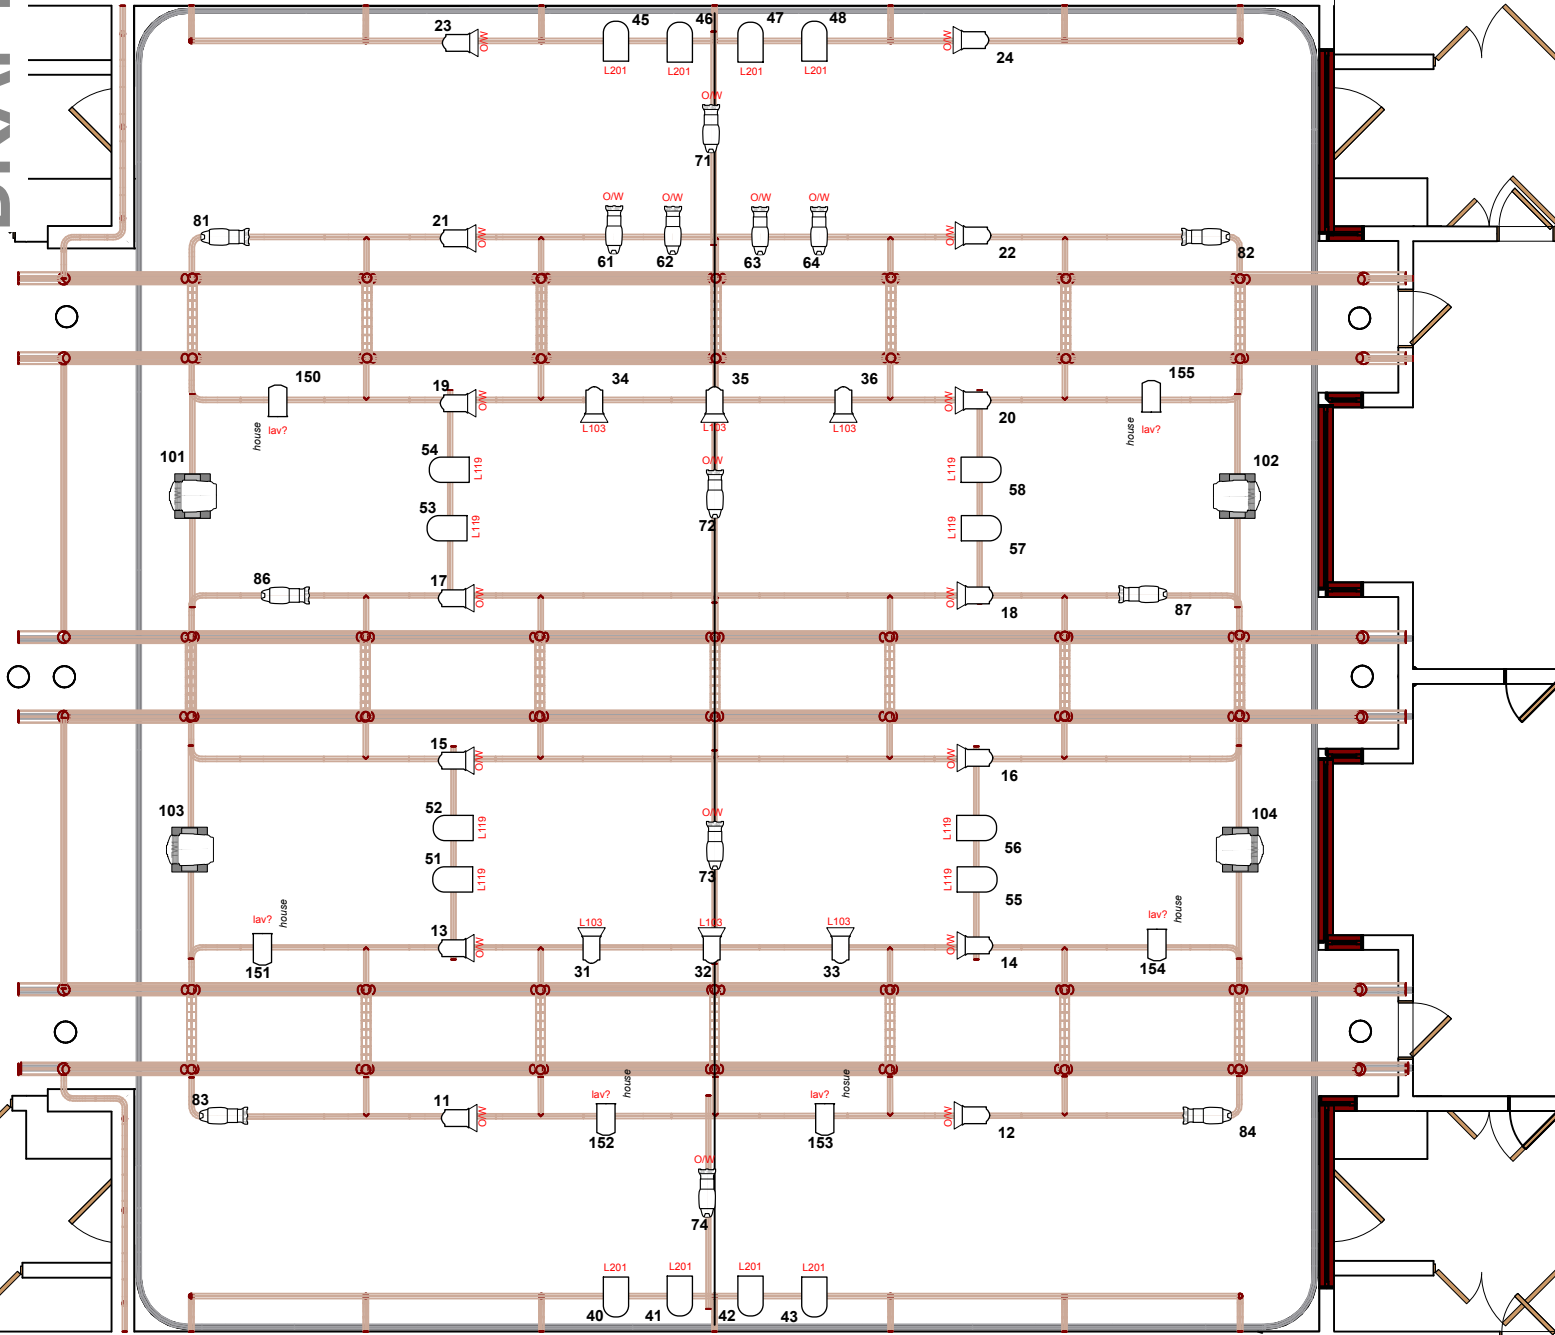

Key to Label Legend

Channel #	Unit #	Colour Ref.
		(+F = + Frost)
Xx		L103F
		focus note
		Gobo Reference
		Colour Reference
		L = Lee Filters
		R = Rosco Filters
		Frost = R119/132

KEY TO INSTRUMENTATION

- Selecon Acclaim Fresnel 650W
- Selecon Acclaim PC 650W
- ETC Source 4 Jnr 25-50 Zoom
- Martin Mac TW1
- PAR 64 - CP62 (WFL)

HAZER : 500

Colour Call

- L201 1/4 CT Blue
- L119 Deep Blue
- L058 Lavender
- L029 Plasa Red
- L103 Straw
- O/W Open White



Royal Conservatoire of Scotland

ALEXANDER RIDGERS
LIGHTING DESIGN



07870657721
ARIDGERS@HOTMAIL.CO.UK

Production Title		Royal Conservatoire of Scotland CPP Year 4 & 1	
Drawing Title		LIGHTING PLAN Version 1	
Designer	Director		
Drawn By	Scale	--	
Venue	Drawing No.	1	
Date		of	
CAD File Name		1	
RCS_CPP_v.1			