


LEYLA

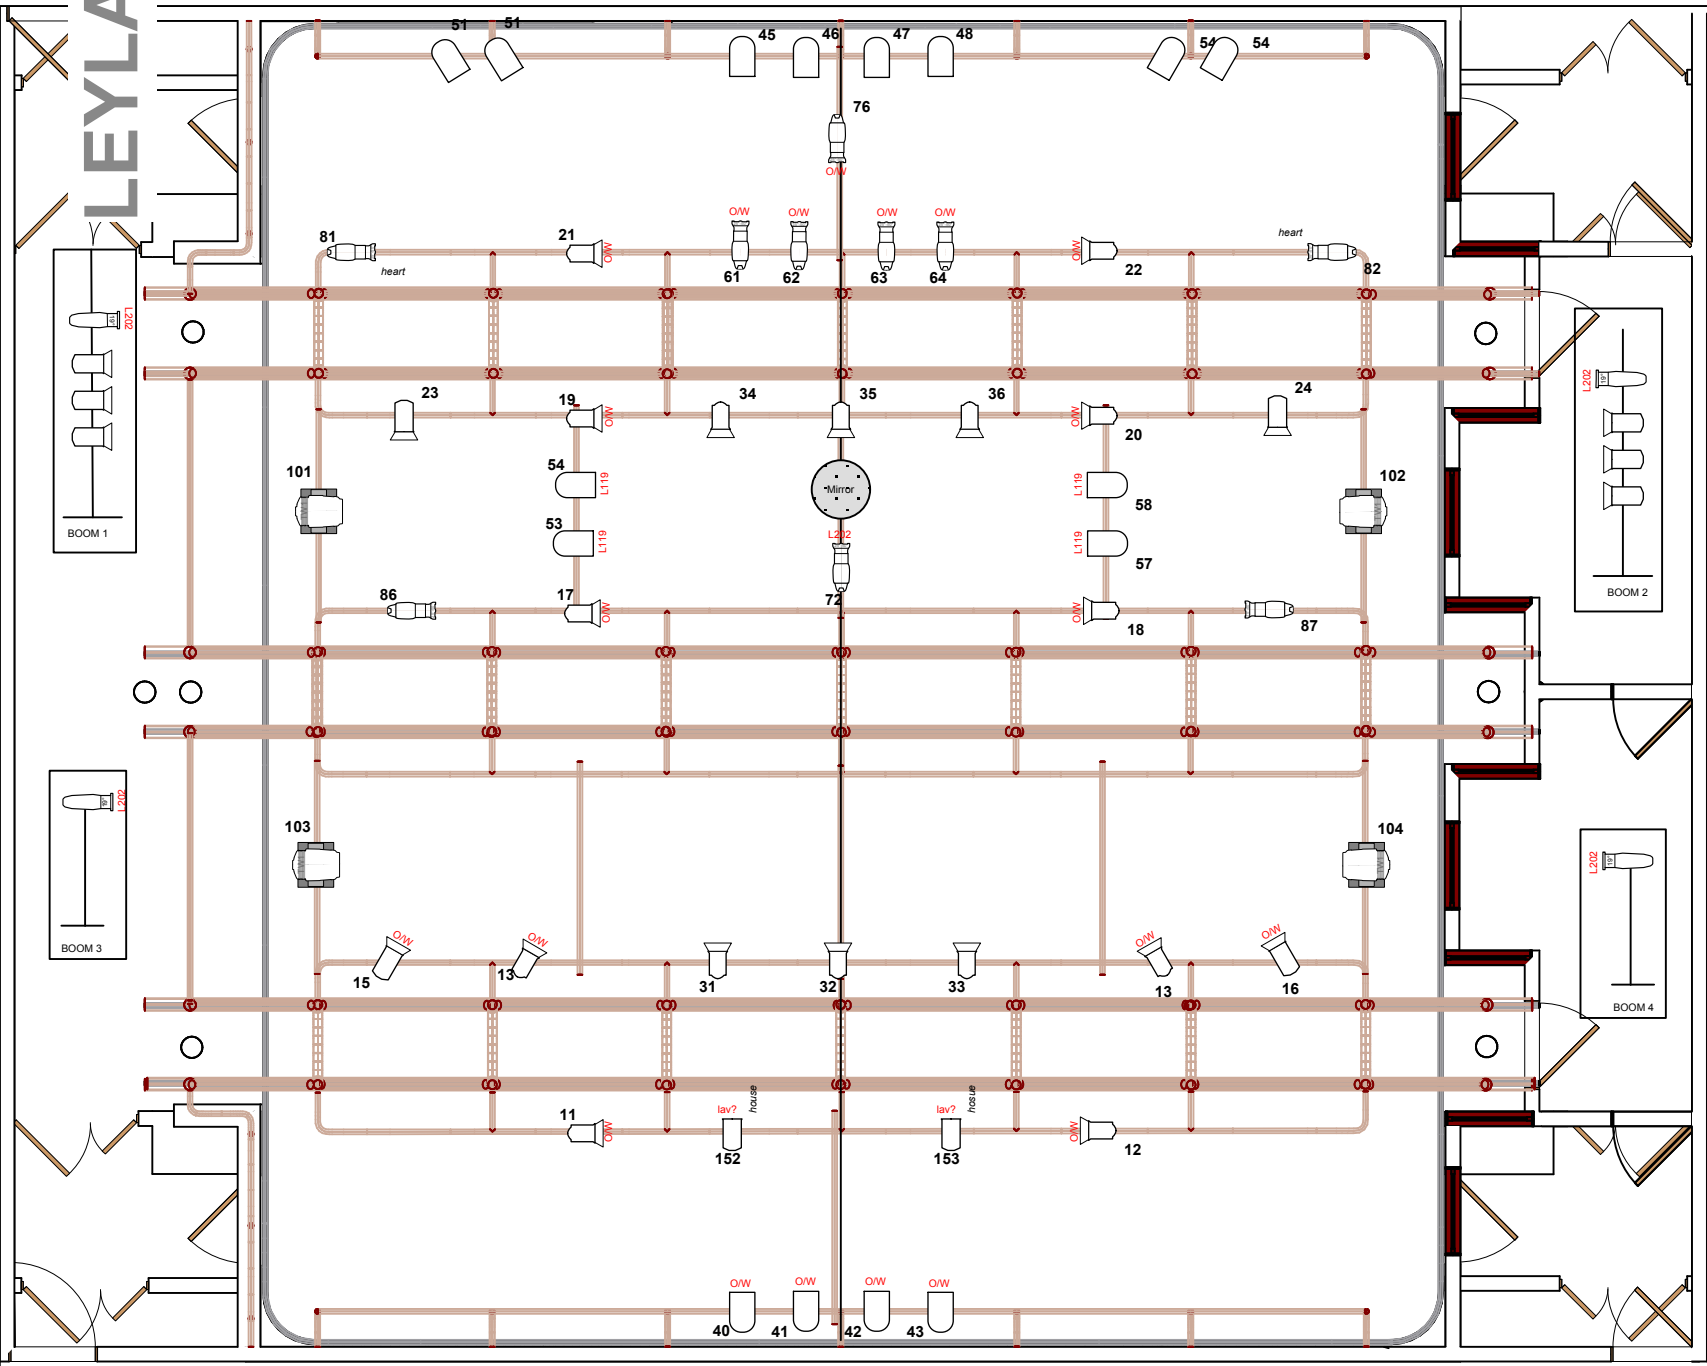

Key to Label Legend

Channel #	Unit #	Colour Ref.
Xx	L119	(+F = + Frost)
	focus note	
	Gobo Reference	Colour Reference
		L = Lee Filters
		R = Rosco Filters
		Frost = R119/132

KEY TO INSTRUMENTATION

- Seleccon Acclaim Fresnel 650W
- Seleccon Acclaim PC 650W
- ETC Source 4 Jrnr 25-50 Zoom
- Martin Mac TW1
- PAR 64 - CP62 (WFL)

HAZER : 500

Colour Call

L201	1/4 CT Blue
L119	Deep Blue
L058	Lavender
L029	Plasa Red
L103	Straw
O/W	Open White



Royal Conservatoire
of Scotland

ALEXANDER RIDGERS
LIGHTING DESIGN



07870857724
A.RIDGERS@HOTMAIL.CO.UK

Production Title		Royal Conservatoire of Scotland CPP Year 4 & 1	
Drawing Title		LIGHTING PLAN Version 3 Update 02/06	
Designer	Director		
Drawn By	Scale		
Venue	Chandler Studio		
Date	June 2013		
CAD File Name	RCS_CPP_v.1		
	1	of	1