


- Robe Robin Pointe - MODE 1
- Robe Robin Spider - MODE 1
- Robe Robin Spikie - MODE 1
- Robe Robin LED Beam 100 - MODE 2
- VL-1000 Tungsten dimmer
- Martin Rush Par - MODE 9Ch
- ETC Source 4 Lustr+ Cyc - MODE 10Ch Direct
- ETC Source 4 Lustr+ 36° - MODE 10Ch Direct
- ETC Source 4 Lustr+ 50° - MODE 10Ch Direct
- ETC Source 4 26°
- ETC Source 4 25-50°
- ETC Source4 PAR NSP
- ETC Source4 PAR WFL
- ADB Lighting 5K
- PAR 64 MFL
- PAR 64 WFL
- Selecon LUI Flood
- ADB Lighting CP50
- Practical

1 - 4	FOH 1st	201 - 208	Rush Booms
5 - 6	FOH 1st DSR/DSL Fill	211 - 212	Rush UpStage
11 - 15	FOH 2nd		
21 - 36	FPH 2nd Slips	221 - 232	Lustr + Booms
31 - 34	PAR Fill 2nd Pros		
41	Sk	251 - 254	Lustr + BP Top
		261 - 264	Lustr + BP Bottom
51 - 54	VL 1000 FOH Truss		
		301 - 306	Pars SR Truss
111 - 118	Truss Grid 100s	311 - 316	Pars SL Truss
121 - 128	Truss Grid Spikies	321 - 326	Pars US Truss SR
131 - 138	Truss Grid 100s	331 - 336	Pars US Truss SL
141 - 148	Truss Grid Pointies		
151 - 158	Truss Grid Spikies	401 - 404	S4 Pars Set DSR
161 - 168	Truss Grid 100s	411 - 424	S4 Pars Set DSL
171 - 178	Truss Grid Pointies	421 - 424	S4 Pars Set USR
181 - 188	Truss US Spiders	431 - 434	S4 Pars Set USL
601	LED Tape SR	501	Hazer
602	LED Tape SL	511	Smoke Machine 1
701 - 705	Birdies	512	Smoke Machine 2
GROUPS			
100	All 100s	901 - 906	Grill Floods
101	All Spikies	911 - 915	Grill Source 4s
102	All Pointies		
103	All Spiders		
200	All Rush Pars	300	All Truss Pars
201	All Rush Sides		
202	Rush Up Stage	400	All S4 Set Pars

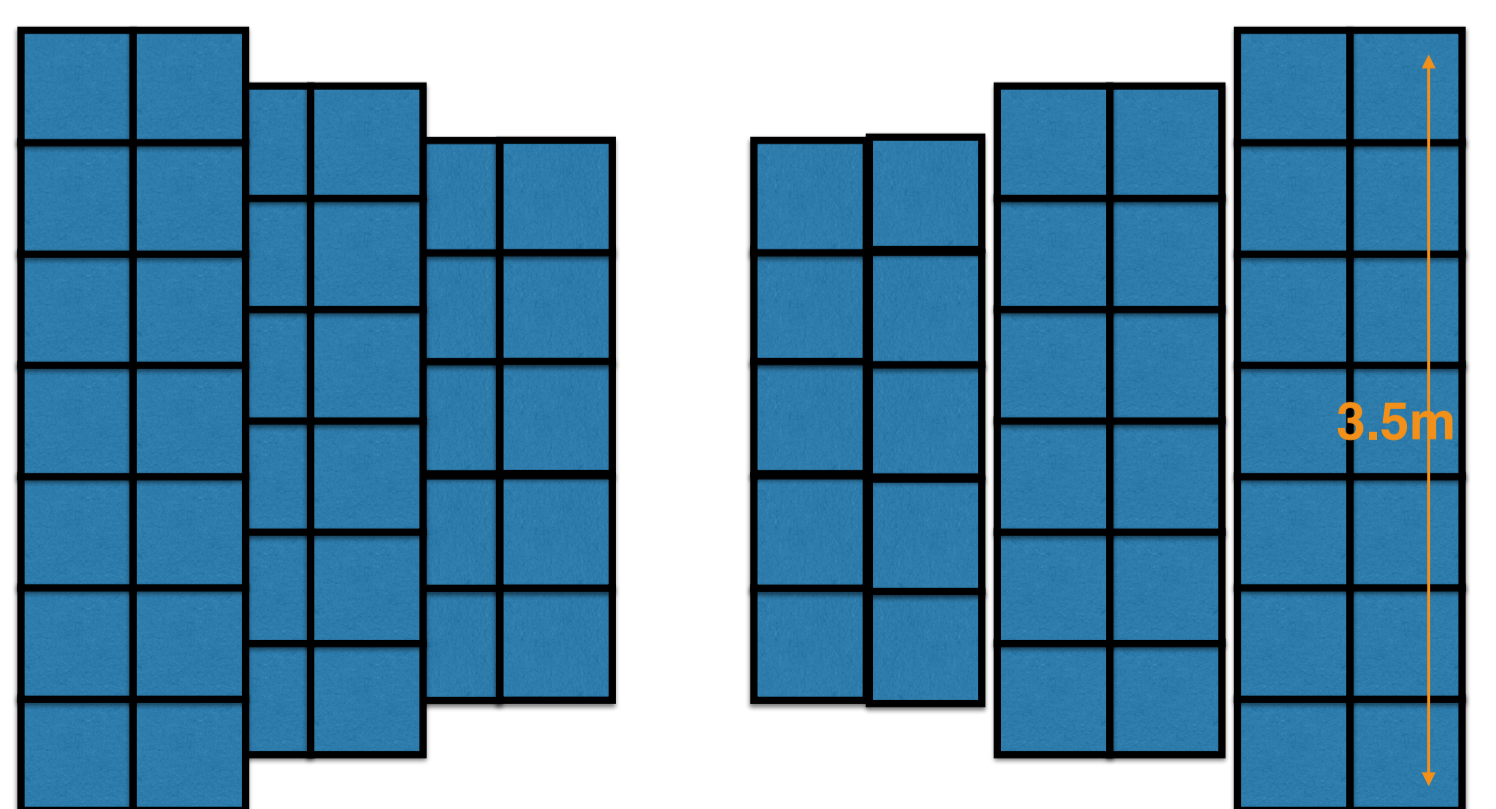

B
72 tiles

NOTES
 - Lantens on Booms are drawn at unit lens height.
 - All Par 64s on Trusses to be overrigged on the DS cord,
 - All units in the "FLOOR" position require final placement on site.
 - See Key for Fixture Modes.
 - FOH purley schematic. To be determined at venue.



1. This drawing is copyright of Grant Anderson and is provided in good faith. It is an artistic rendering of a design idea only and should not be interpreted as a binding instruction to any person or organization assembling light structures, fittings or scenery based on this drawing. It is the responsibility of the producer or client commissioning this drawing to ensure that the full structural integrity of anything being rigged to this plan is sound. All resulting working practices from this plan must fall in line with current Health & Safety law and valid risk assessments must have been put in place. Grant Anderson will not accept any liability for any injury or loss as a consequence, direct or indirect, arising as a result of electrical fixtures, structures or scenery constructed on the basis of the drawing.

GXL DESIGNS
 1926

Production Title		CHESS The Musical	
Drawing Title		Lighting Plan Version 4	
Lighting Designer	Grant Anderson	Director	Andrew Pantton
Designer	Kenneth MacLeod	Scale	1:50 @ A1
Venue	Edin Festival Theatre	Drawing No.	A1
Date	23 March 2017		of
CAD File Name	Chess 2017 LP		1