



# TRON Changing House

Plan updated 28/08/2014 by MH

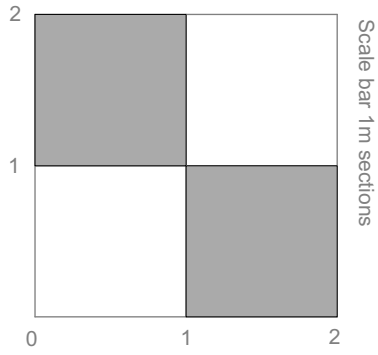

- Starlette 1kw
- Quarlet 650w
- 28/50 S4 Jr 575w
- 16/ 30 Prelude 650w
- 28/40 Prelude 650w
- PAR MR- 16- Birdie- VNSP

**Z** Fairy Lights

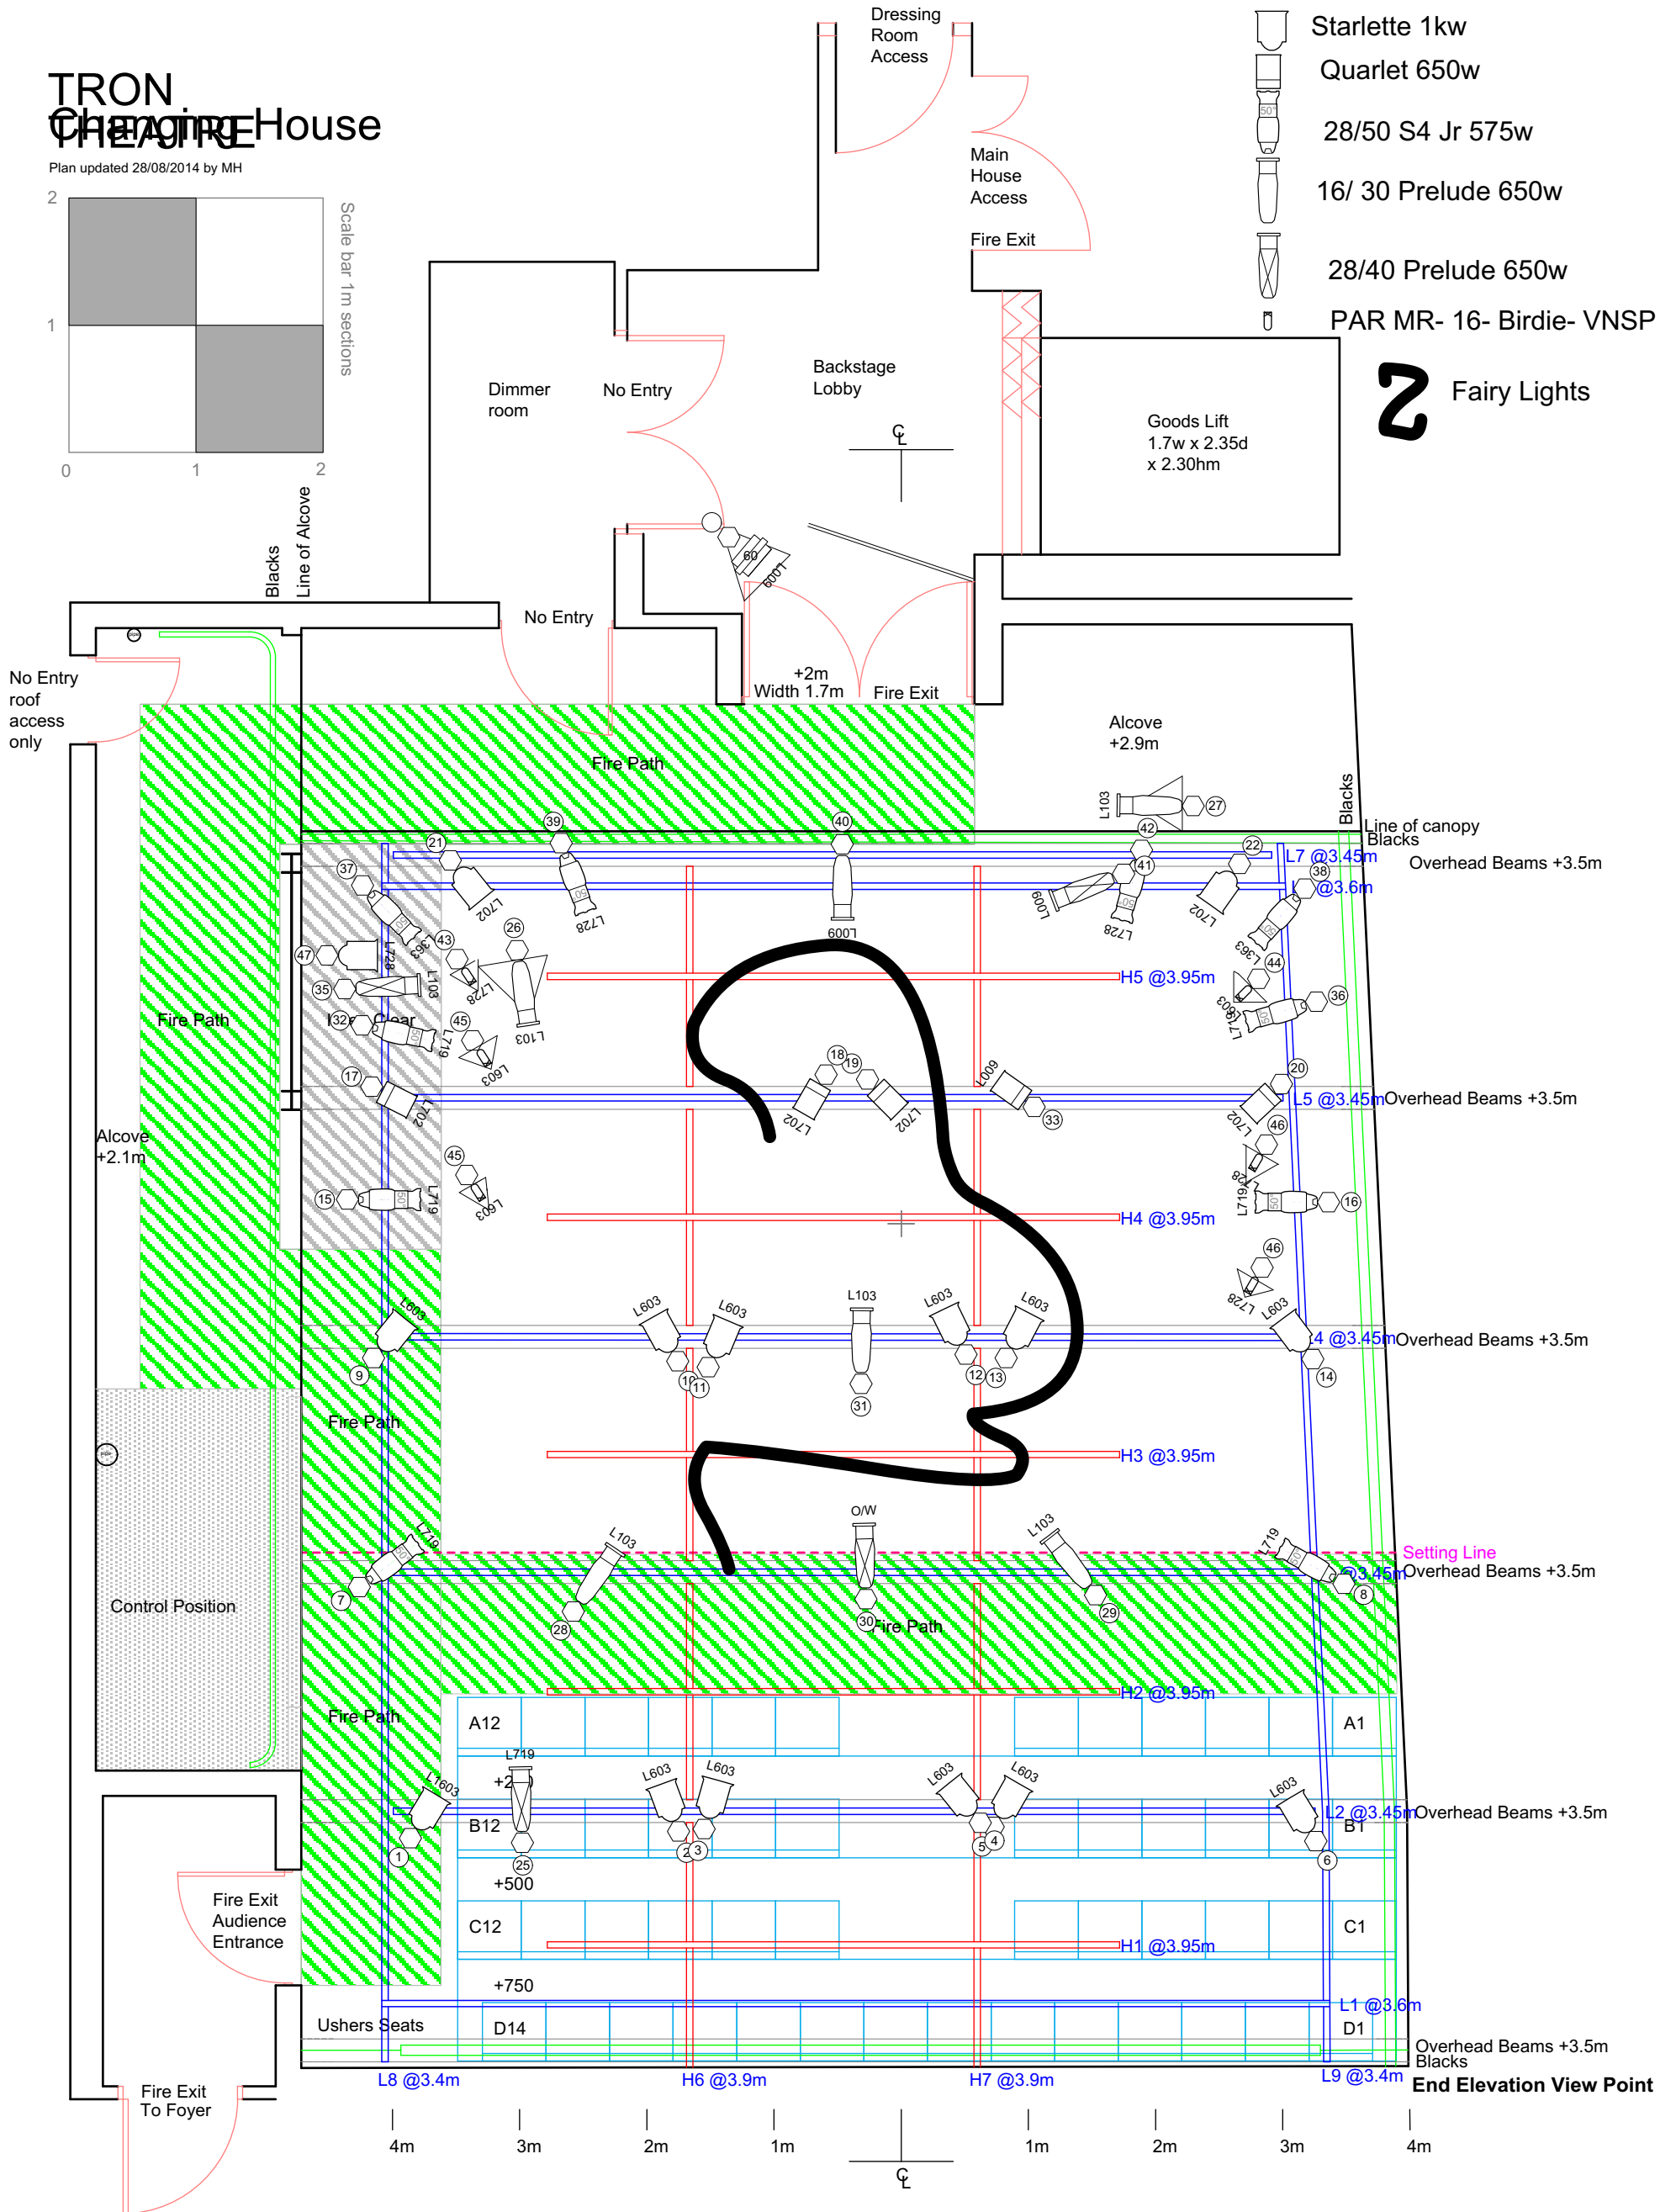

## VENUE INFORMATION

For Lighting information see document: **Changing House - Lighting Rig Info**  
Control Position is to the SR of stage area

Notes  
FIGURED DIMENSION TO BE TAKEN IN PREFERENCE TO SCALED DIMENSIONS  
ALL DIMENSIONS TO BE CHECKED ON SITE

Tron Theatre Ltd, 63 Trongate, Glasgow, G1 5HB  
Box Office: 0141 552 4267  
Bar Kitchen: 0141 552 8587

Tron Theatre Ltd is a Scottish registered charity, No: SC012081  
Glasgow City Council  
Creative Scotland

Scale 1:50 @ A3

Show Name <b>Charlie Sonata 1:50</b>		
Reference <b>Lighting Plan</b>	Drawn By <b>Alex Kilgour</b>	Date <b>08/06/2015</b>
CAD File Name <b>Changing House, Tron Theatre</b>		